
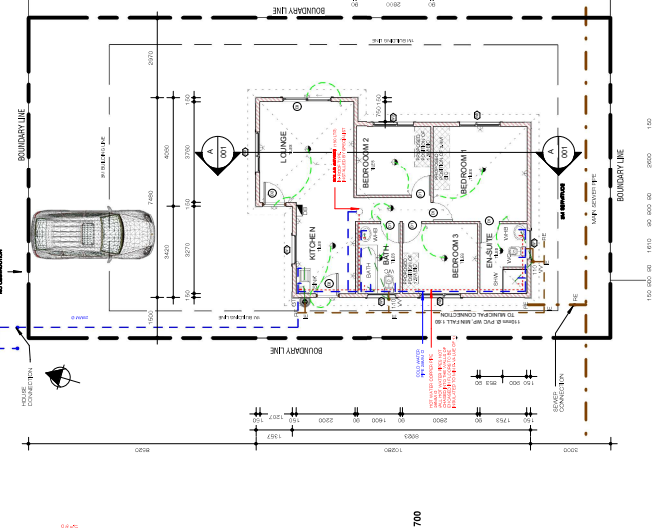
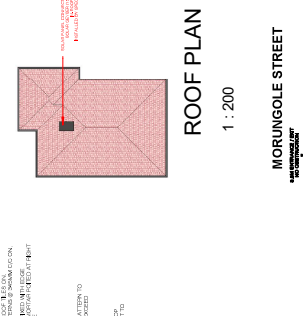
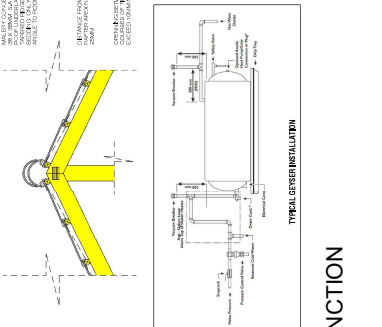
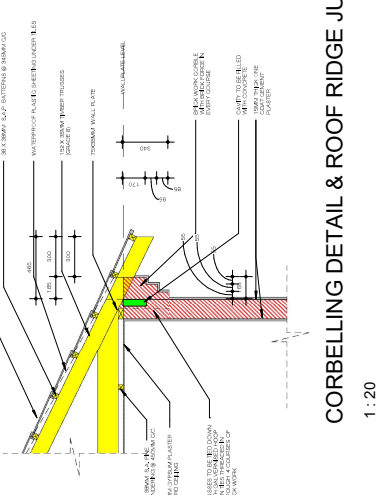
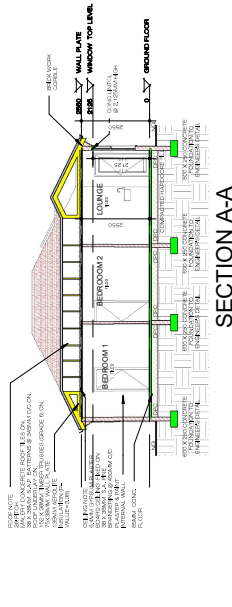
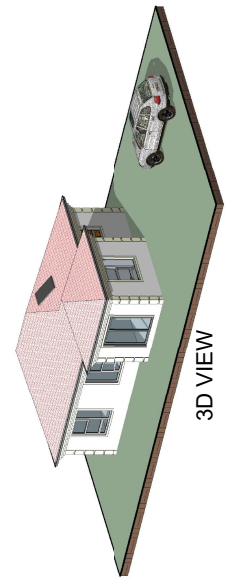
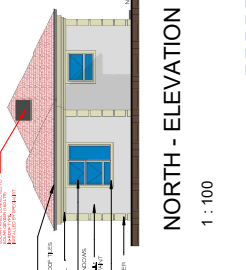
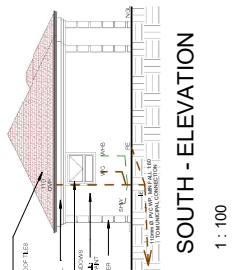


NO.	TYPE	SIZE	LOCATION	FINISH	GLASS	OPERATION	MARKING	NOTES
1	Window	1500 x 1500	Living Room	White	Double Glazed	Manual	1500 x 1500	See Section A-A
2	Window	1500 x 1500	Bedroom 1	White	Double Glazed	Manual	1500 x 1500	See Section A-A
3	Window	1500 x 1500	Bedroom 2	White	Double Glazed	Manual	1500 x 1500	See Section A-A
4	Window	1500 x 1500	Bedroom 3	White	Double Glazed	Manual	1500 x 1500	See Section A-A
5	Window	1500 x 1500	Bedroom 4	White	Double Glazed	Manual	1500 x 1500	See Section A-A

WINDOW SCHEDULE
1 : 100

NO.	TYPE	SIZE	LOCATION	FINISH	GLASS	OPERATION	MARKING	NOTES
1	Door	1500 x 2100	Living Room	White	Double Glazed	Manual	1500 x 2100	See Section A-A
2	Door	1500 x 2100	Bedroom 1	White	Double Glazed	Manual	1500 x 2100	See Section A-A
3	Door	1500 x 2100	Bedroom 2	White	Double Glazed	Manual	1500 x 2100	See Section A-A
4	Door	1500 x 2100	Bedroom 3	White	Double Glazed	Manual	1500 x 2100	See Section A-A
5	Door	1500 x 2100	Bedroom 4	White	Double Glazed	Manual	1500 x 2100	See Section A-A

DOOR SCHEDULE
1 : 100

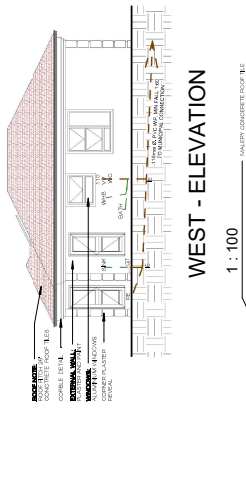


SANS 10400 PART A1 NOTES

CONCRETE
CONCRETE SHALL BE SUPPLIED TO THE SPECIFIED STRENGTH AND SHALL BE CAST AND CURED IN ACCORDANCE WITH THE REQUIREMENTS OF SANS 10400 PART A1.

REINFORCEMENT
REINFORCEMENT SHALL BE SUPPLIED TO THE SPECIFIED YIELD STRENGTH AND SHALL BE CAST AND CURED IN ACCORDANCE WITH THE REQUIREMENTS OF SANS 10400 PART A1.

WALL FINISHES
WALL FINISHES SHALL BE SUPPLIED TO THE SPECIFIED FINISH AND SHALL BE CAST AND CURED IN ACCORDANCE WITH THE REQUIREMENTS OF SANS 10400 PART A1.

ROOF FINISHES
ROOF FINISHES SHALL BE SUPPLIED TO THE SPECIFIED FINISH AND SHALL BE CAST AND CURED IN ACCORDANCE WITH THE REQUIREMENTS OF SANS 10400 PART A1.

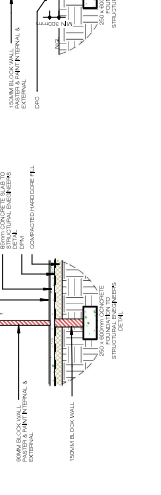

ELECTRICAL LEGEND

○	SWITCH
□	OUTLET
○	RECEPTACLE
○	CONDUIT
○	WALL LIGHT
○	ROSE FLOWER
○	ROSE BUSH
○	ROSE BUSH
○	ROSE BUSH

EXTERNAL WALL CALCULATIONS

PARAMETER	UNIT	VALUE	REFERENCE
EXTERNAL WALL AREA	m ²	120	S.10
INTERNAL WALL AREA	m ²	120	S.10
TOTAL	m ²	240	S.10

FENESTRATION CALCULATIONS

NO.	TYPE	SIZE	LOCATION	FINISH	GLASS	OPERATION	MARKING	NOTES
1	Window	1500 x 1500	Living Room	White	Double Glazed	Manual	1500 x 1500	See Section A-A
2	Window	1500 x 1500	Bedroom 1	White	Double Glazed	Manual	1500 x 1500	See Section A-A
3	Window	1500 x 1500	Bedroom 2	White	Double Glazed	Manual	1500 x 1500	See Section A-A
4	Window	1500 x 1500	Bedroom 3	White	Double Glazed	Manual	1500 x 1500	See Section A-A
5	Window	1500 x 1500	Bedroom 4	White	Double Glazed	Manual	1500 x 1500	See Section A-A

AREA SCHEDULE

ITEM	UNIT	VALUE
GRAND TOTAL AREA	m ²	46.50
PERCENTAGE	%	1.00

CLIENT JOHN MPHUTI
PROJECT NEW DWELLING
STAND ERF 1689
SUBURB ALLANCE EXT 3
DRAWING NO. 001
DATE 01/01/2024
SCALE As Indicated

ZIBIRIWA CONSTRUCTION & PROJECTS
ARCHITECTURE
CELL 083 643 7781
EMAIL: zibiriwa@zibiriwa.com
CELL: 079 818 8305
079 818 8305